


May 06, 2008 - 14:58:02 Location: G:\Projects\127\127-01-100\Drawn\Exist-dwg\FloorPlan.dwg

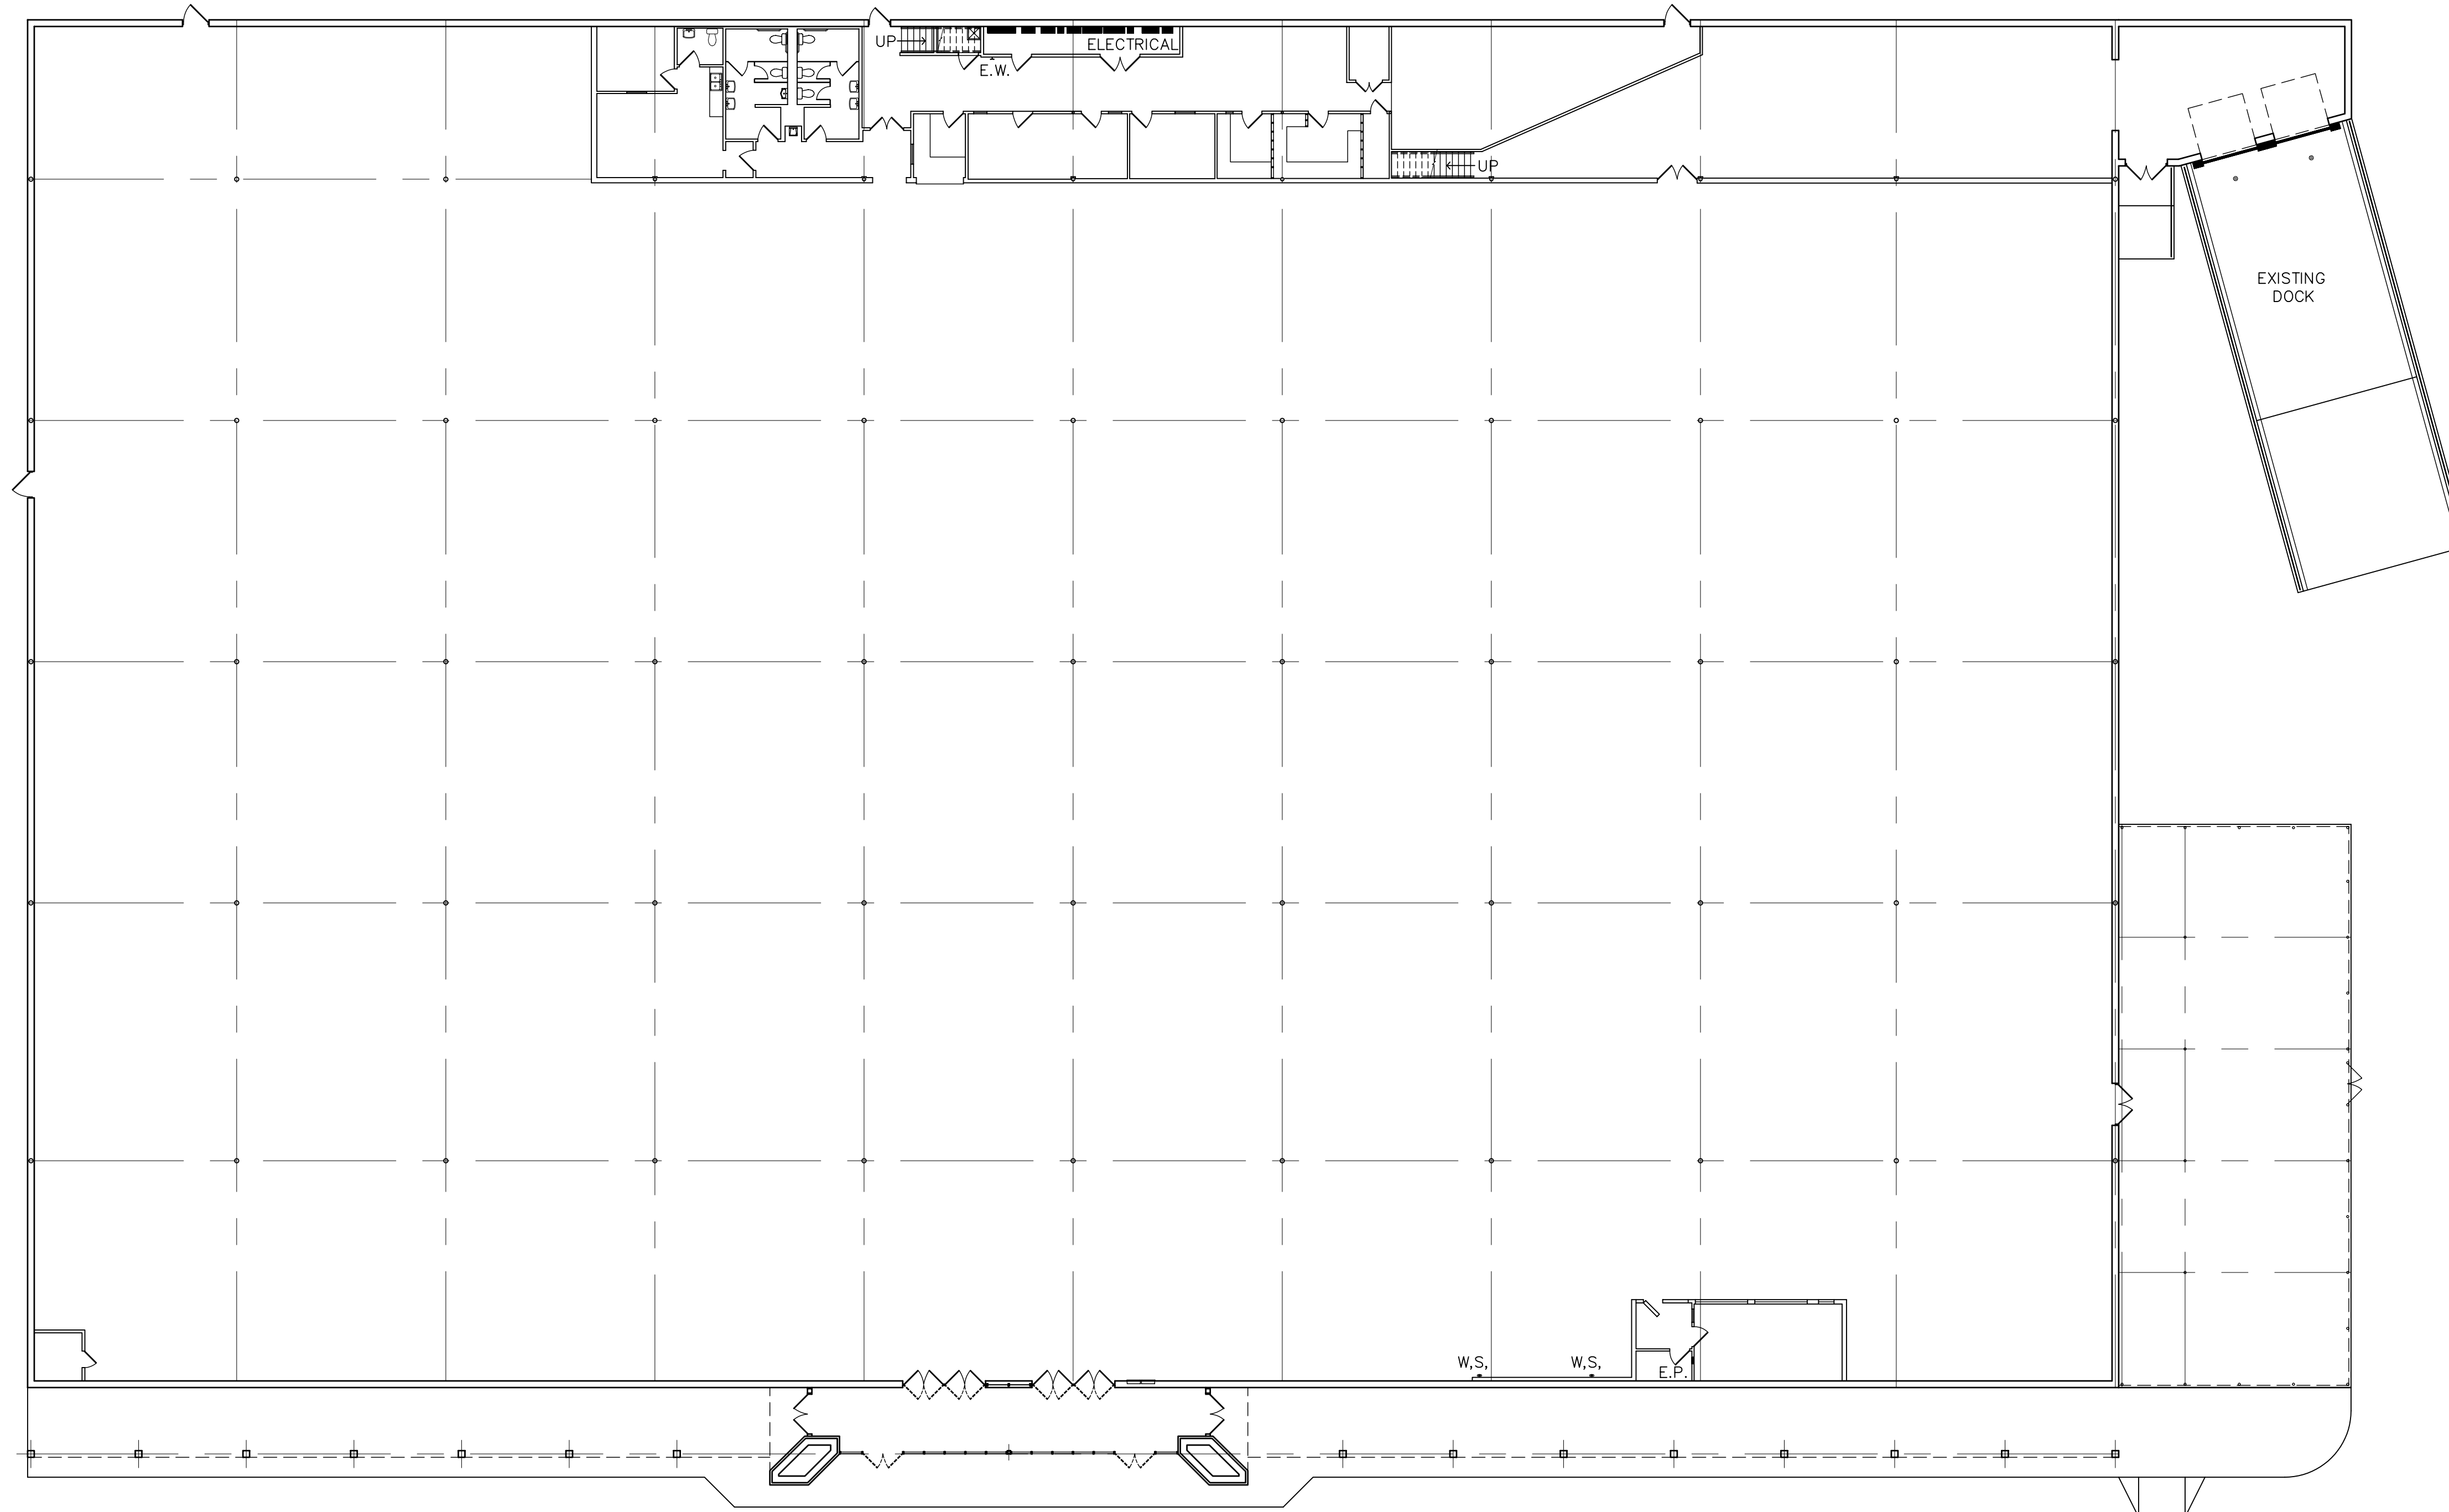

W.S. - EXISTING WATER STUB-IN
 E.P. - EXISTING ELECTRICAL PANEL
 E.W. - EXISTING EYE WASH

EXISTING FLOOR PLAN
 SCALE: 1/16" = 1'-0"

REVISIONS	BY



Miller & Associates
 Consulting Engineers, P.C.
 Kearney, NE (308) 234-6466
 McCook, NE (308) 345-3710

EXISTING WAL-MART STORE
EXISTING FLOOR PLAN
 LEXINGTON, NEBRASKA

This document, and the ideas and designs incorporated herein, as an instrument of professional service, is the property of Miller & Associates and is not to be used in whole or in part, for any other project without the written authorization of Miller & Associates.

VERIFY SCALES

BAR IS ONE INCH ON ORIGINAL DRAWING
 0 1"
 IF NOT ONE INCH ON THIS SHEET, ADJUST SCALES ACCORDINGLY.

SCALE:	AS NOTED
PROJECT NO.	127-G1-100
DATE:	MAY 2008
FIELD BOOK	NA
M&A DWG NO.	
DRAWN BY:	CCB
APRVD BY:	
SHEET	A-1 OF